


Statistics				
Description	Symbol	Avg	Max	Min
Calc Zone #1	+	0.31c	1.521c	0.07c
		N/A	N/A	N/A

Symbol	Label	Quantity	Manufacturer	Color	Notes
(Symbol)	A	57	SELESTIONS	120-277V	EXCLUDE FIRST TOP TOWN & COUNTY

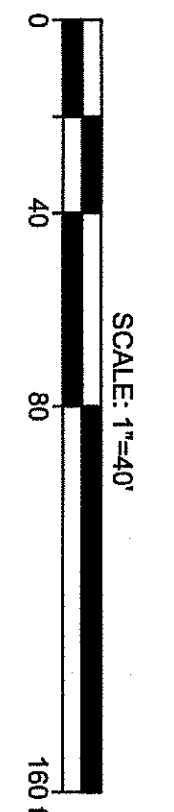

THESE PLANS ARE NOT TO BE USED FOR BID OR CONSTRUCTION

PLANS ARE FINAL FOR SANITARY SEWER AND WATER MAIN DESIGN

PRELIMINARY AND FINAL MAJOR SUBDIVISION & PRELIMINARY AND FINAL SITE PLAN
 TAX MAP SHEET 166 DATED 12/1987, REV 04-10-01 AND SHEET 174 DATED 12/1987, REV 5-12-2003
EL at MARLBORO 79, LLC - MARLBORO PARKE
LIGHTING PLAN

BLOCK 415, LOT 22
 TOWNSHIP OF MARLBORO, MONMOUTH COUNTY, NEW JERSEY

Bowman Consulting Group, Ltd.
 303 W. Main Street
 Freehold, New Jersey 07728
 www.bowmanconsulting.com
 E-mail: NJ@BowmanConsulting.com

Phone: 732-686-5500
 FAX: 732-686-5501
 NJ Certificate of Authorization
 No. 24GA26222600

Sean A. Delany
 SEAN A. DELANY, N.J. Professional Engineer, Lic. 24GE0447100



PRJ: 080726-F1-003
 DATE: 01.17.2020
 CHKD: SMD
 THE DRAWING AND ALL INFORMATION CONTAINED HEREIN IS AUTHORIZED FOR USE ONLY BY THE PARTY FOR WHOM THE DESIGN WAS CONTRACTED OR TO WHOM IT IS OTHERWISE DISCLOSED. WITHOUT THE WRITTEN CONSENT OF BOWMAN CONSULTING GROUP, LTD., ALL RIGHTS RESERVED.

REVISION	DATE	CHKD
1	REVISIONS AS PER MARCH 6, 2020 CME REVIEW LETTER	4/20/20
2		
3		
4		
5		
6		
7		
8		
9		
10		
11		
12		

Schedule	Label	Quantity	Unit	Percentage	Count	Weight	Avg	Min	Max	AvgMin
01	A	99	FT	100.00%	99	0.00	0.00	0.00	0.00	0.00



BENCHMARK
 TOP OF IRON PIN
 ELEV: 192.72

SCALE: 1"=40'

THESE PLANS ARE
 NOT TO BE USED
 FOR BID OR
 CONSTRUCTION

PLANS ARE FINAL FOR SANITARY SEWER AND WATER MAIN DESIGN

PRELIMINARY AND FINAL MAJOR SUBDIVISION & PRELIMINARY AND FINAL SITE PLAN
 TAX MAP SHEET 166 DATED 12/1987, REV 04-10-01 AND SHEET 174 DATED 12/1987, REV 5-12-2003
EL at MARLBORO 79, LLC - MARLBORO PARKE
LIGHTING PLAN
 BLOCK 415, LOT 22
 TOWNSHIP OF MARLBORO, MONMOUTH COUNTY, NEW JERSEY

Bowman Consulting Group, Ltd.
 303 W. Main Street
 Freehold, New Jersey 07728
 www.bowmanconsulting.com
 E-mail: NJ@BowmanConsulting.com
 Phone: 732-665-6500
 FAX: 732-665-6501
 NJ Certificate of Authorization
 No. 24GA2922600

Sean A. Delany
SEAN A. DELANY, N.J. Professional Engineer, Lic. 24GE0447100

Bowman CONSULTING

PROJ: 080726-F1-003
 DATE: 01.17.2020
 CHKD: SMD
 THIS DRAWING AND ALL INFORMATION CONTAINED HEREIN IS AUTHORIZED FOR USE ONLY BY THE PARTY FOR WHOM THE WORK WAS CONTRACTED ON TO. NO PART OF THIS DRAWING IS TO BE DISCLOSED, DISTRIBUTED OR REPRODUCED FOR ANY OTHER PURPOSE WITHOUT THE WRITTEN CONSENT OF BOWMAN CONSULTING GROUP, LTD. ALL RIGHTS RESERVED.

REVISION	DATE	CHKD
1	REVISIONS AS PER MARCH 6, 2020 CME REVIEW LETTER: 4/20/20	
2		
3		
4		
5		
6		
7		
8		
9		
10		
11		
12		

SHEET NO. 11 B